





F-10-05A

SALES GAS FILTER COALESCER

SIZE : 27" ID X 10.5' TL/WL (690MM ID X 3200MM TL/WL)
DESIGN : 1650 PSIG @ -20/200°F (1137 KPAG @ -29/93°C)
CA : 0.0625" (1.58MM)
MAT'L : CS

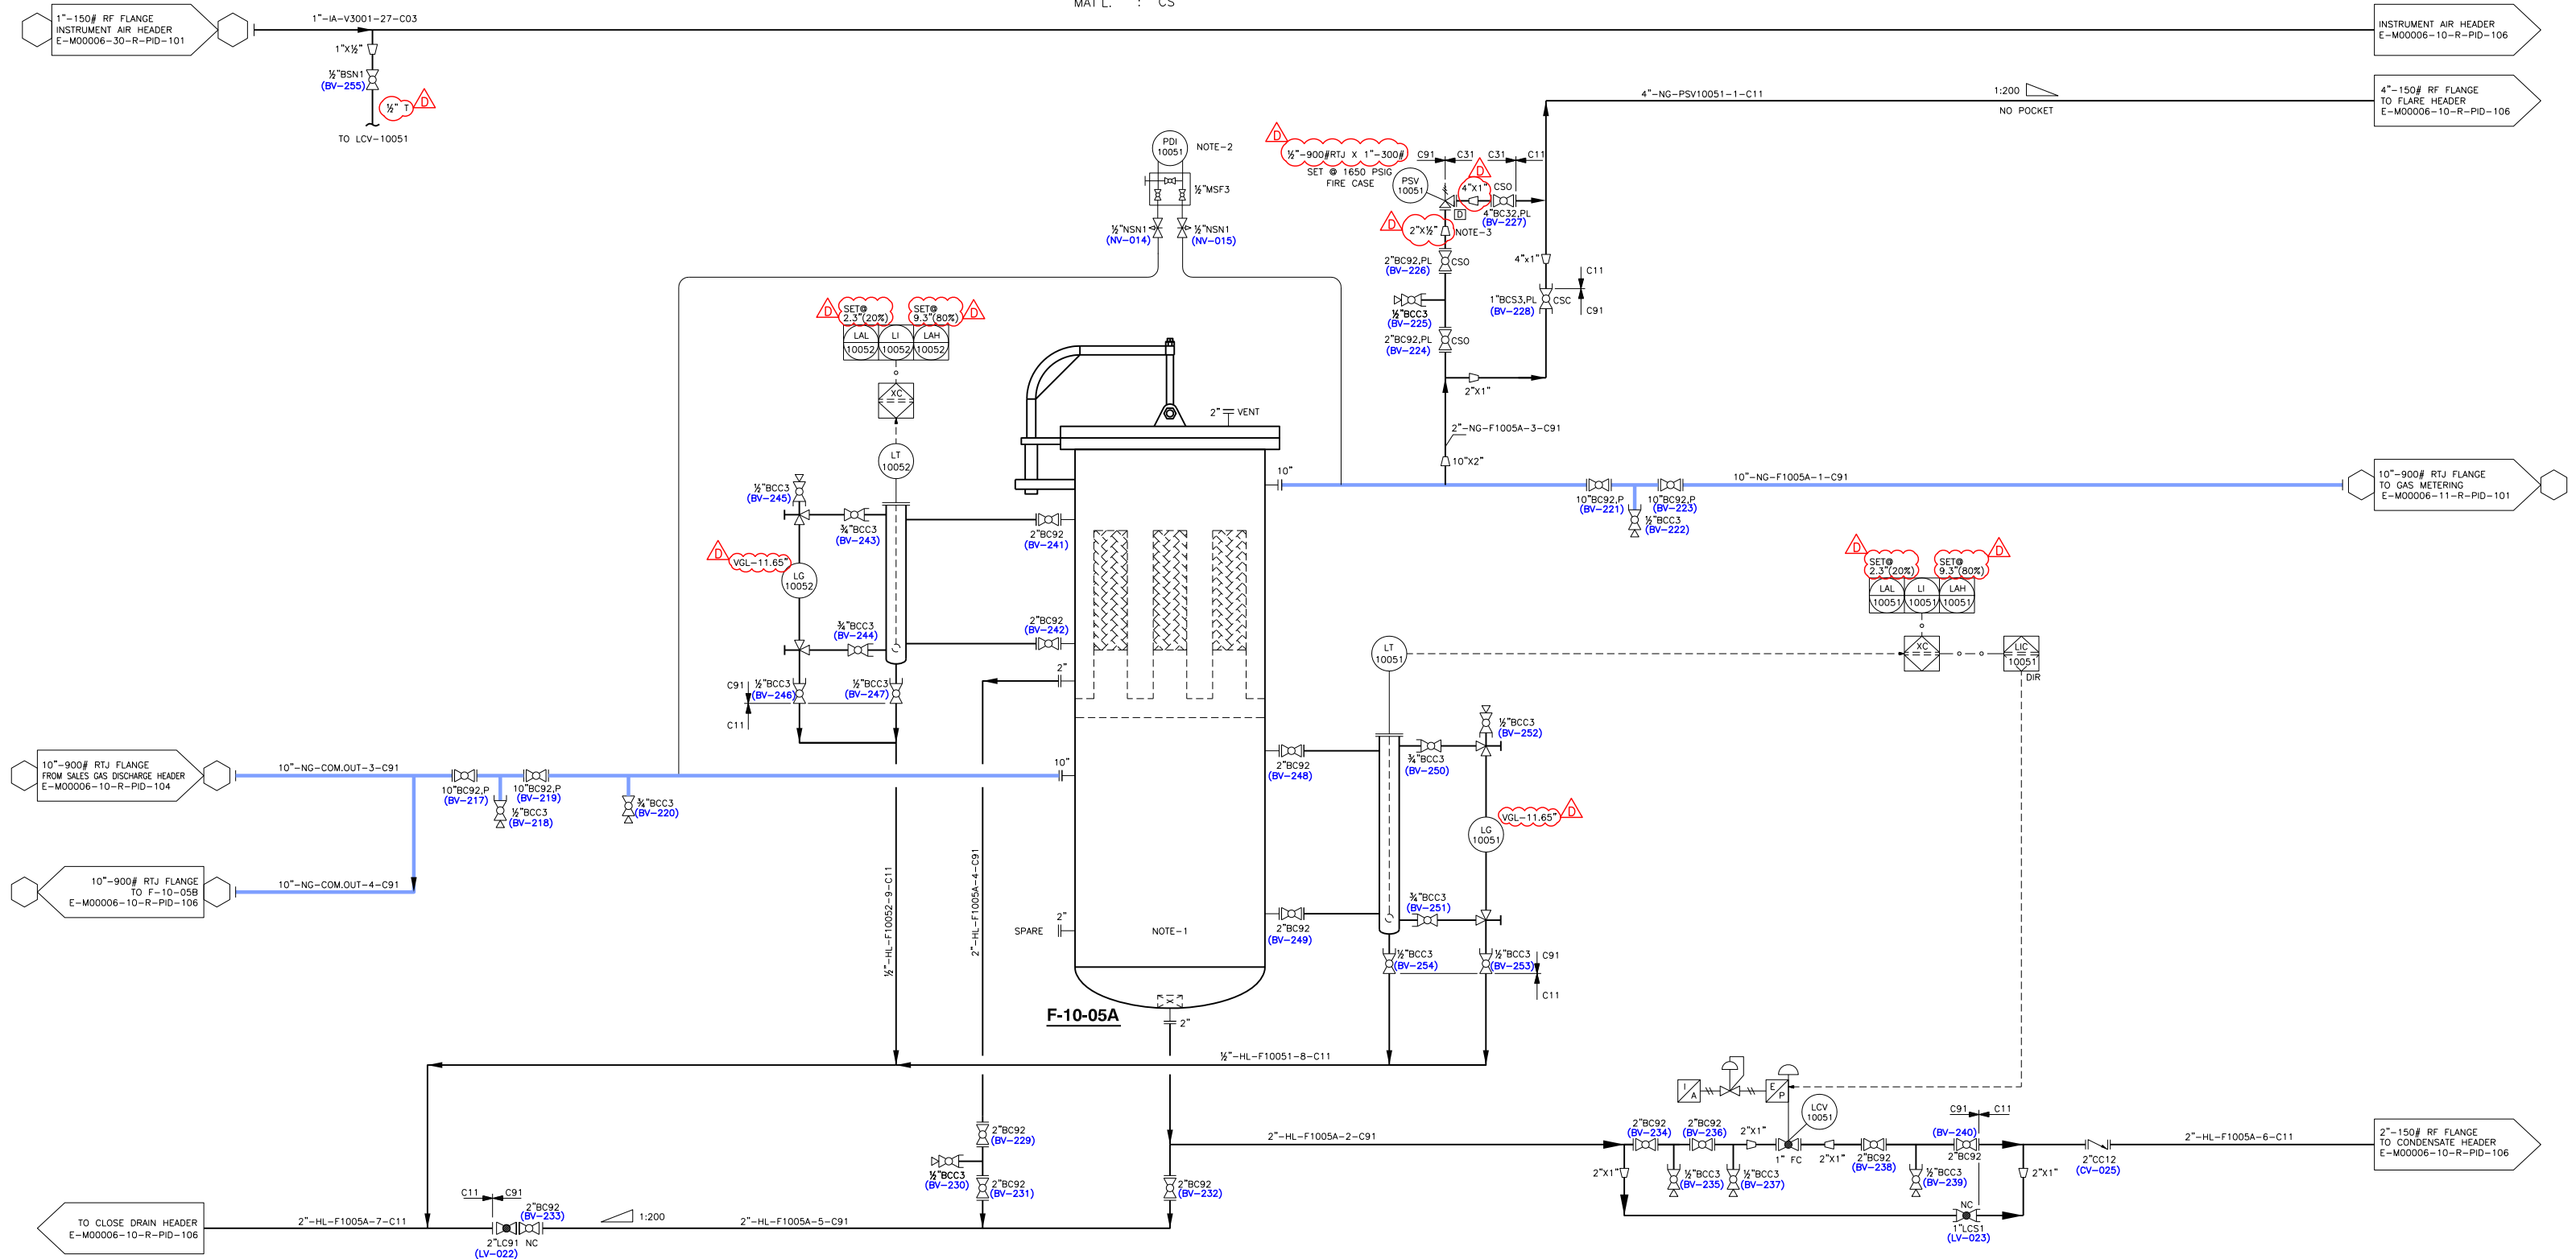

NOTE:
1) 10µ @ 99.9% REMOVAL EFFICIENCY.
2) ALLOWABLE PRESSURE DROP IS 15 PSI, CRUSH PRESSURE DROP IS 20 PSI.
3) REDUCERS TO BE INSTALLED AS CLOSE AS POSSIBLE TO PSV.

					DATE	10/08/15		SCALE	NTS			OCCIDENTAL OMAN GAS COMPANY LLC BLOCK 62 GAS PLANT RENTAL PROJECT		ENERFLEX MIDDLE EAST LTD. ABU DHABI	SALES GAS COMPRESSION			
D	AS MARKED	05/01/15	WH	SAH	DRAWN BY	WH	CHECKED BY	FUB	APPROVED BY	SAH					P&ID-SALES GAS FILTER COALESCER			
C	HAZOP COMMENTS INCORPORATED	26/10/15	WH	SAH	PROJECT MANAGER		PROJECT ENGINEER											
B	ISSUED FOR HAZOP-RECONFIGURED GAS PLANT	28/08/15	WH	SAH	CUSTOMER REF. HAB-CA-2014-2400047991													
A	ISSUED FOR REVIEW	10/08/15	WH	SAH														
REV	DESCRIPTION		DATE	BY	APR	PROJECT NO. E-M00006			STEP CODE		WORK ORDER	DWG NO	E-M00006-10-R-PID-105		SHT TTL	1 OF 1	REV	

STAGE-1