


- NOTES:
2. PROVIDE GAS CONNECTION KIT AS PER MANUFACTURER'S RECOMMENDATIONS, AND FOLLOW CODE REGULATIONS.
 3. PROVIDE PRESSURE REGULATORS FOR EACH EQUIPMENT AS RECOMMENDED BY GAS COMPANY AND UNIT MANUFACTURERS.
 4. PROVIDE UNION AND DRIP LEG AT EACH EQUIPMENT AND AT GAS METER.
 5. PROVIDE SHUT-OFF COCK AT GAS MAIN AND AT EACH EQUIPMENT.

BASIS OF DESIGN:
 MAX DISTANCE: 200'
 INITIAL PRESSURE: < 2.0 PSIG
 PRESSURE DROP: 0.5" WC
 SPECIFIC GRAVITY: 0.60

NATURAL GAS RISER DIAGRAM

NO SCALE

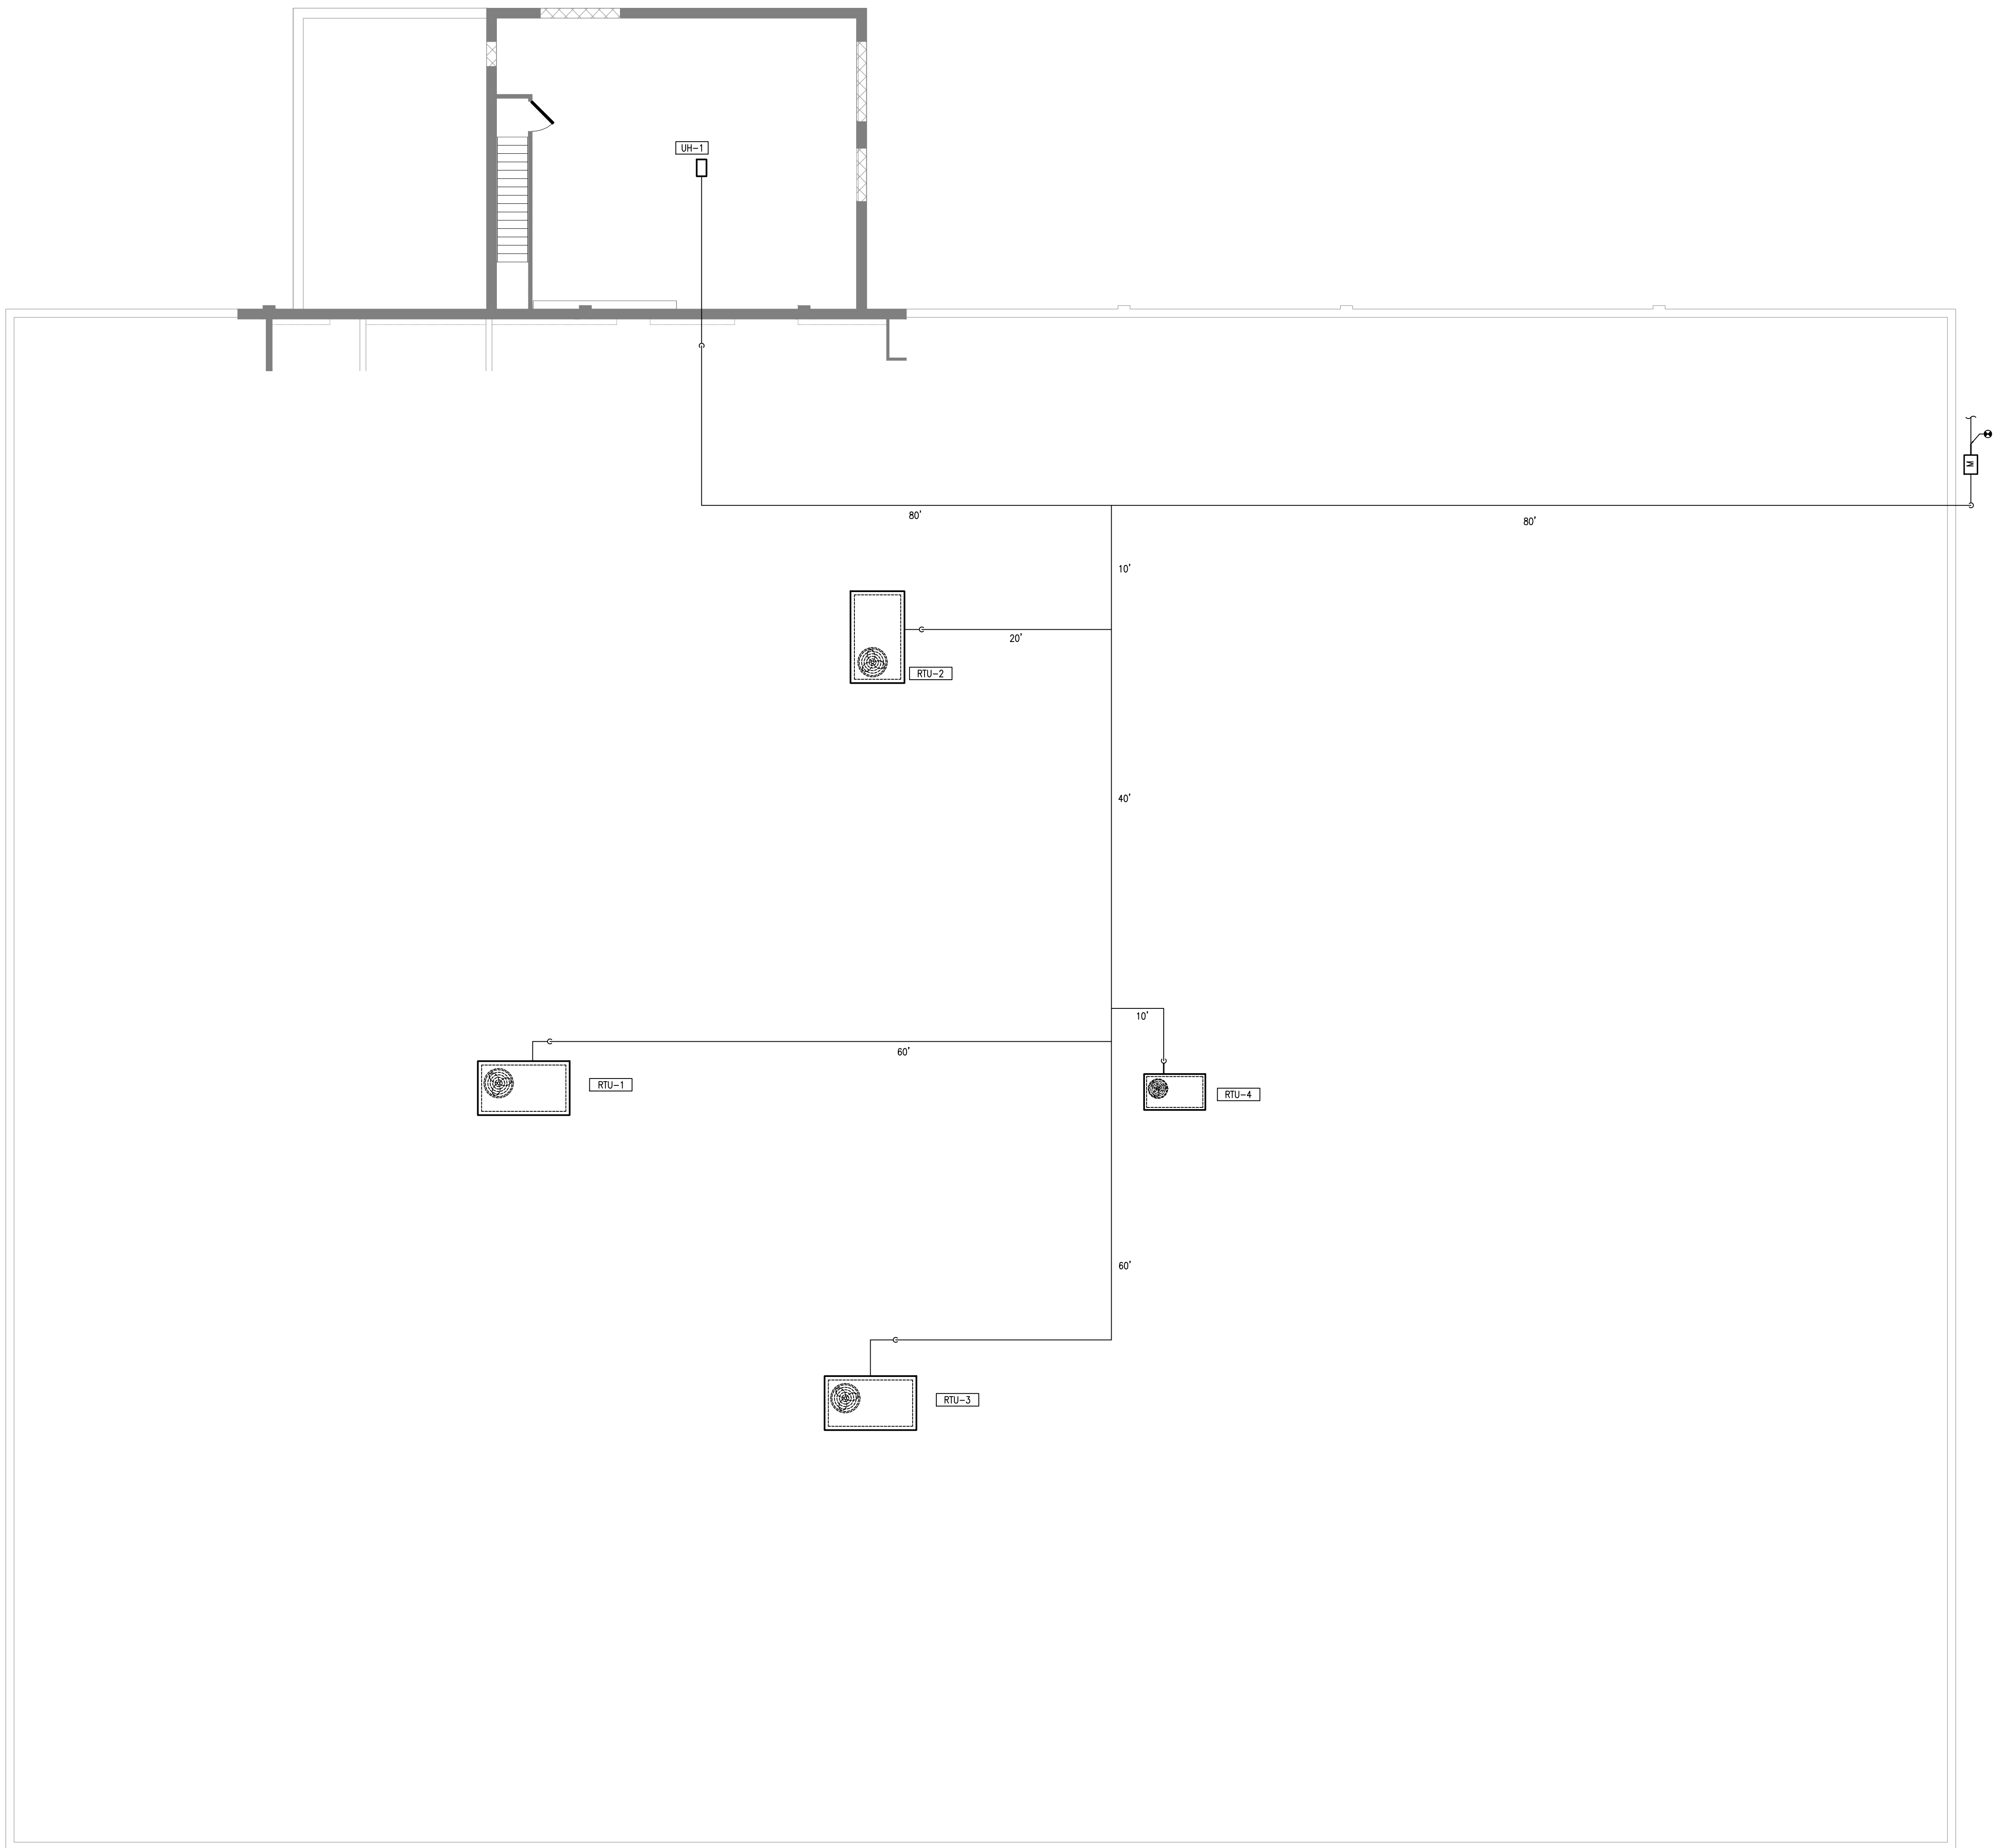

ROOF PLAN -NEW WORK

SCALE: 1/8"=1'-0"