


FLOOR & ELECTRICAL PLAN  
SCALE: 1/4" = 1'-0"

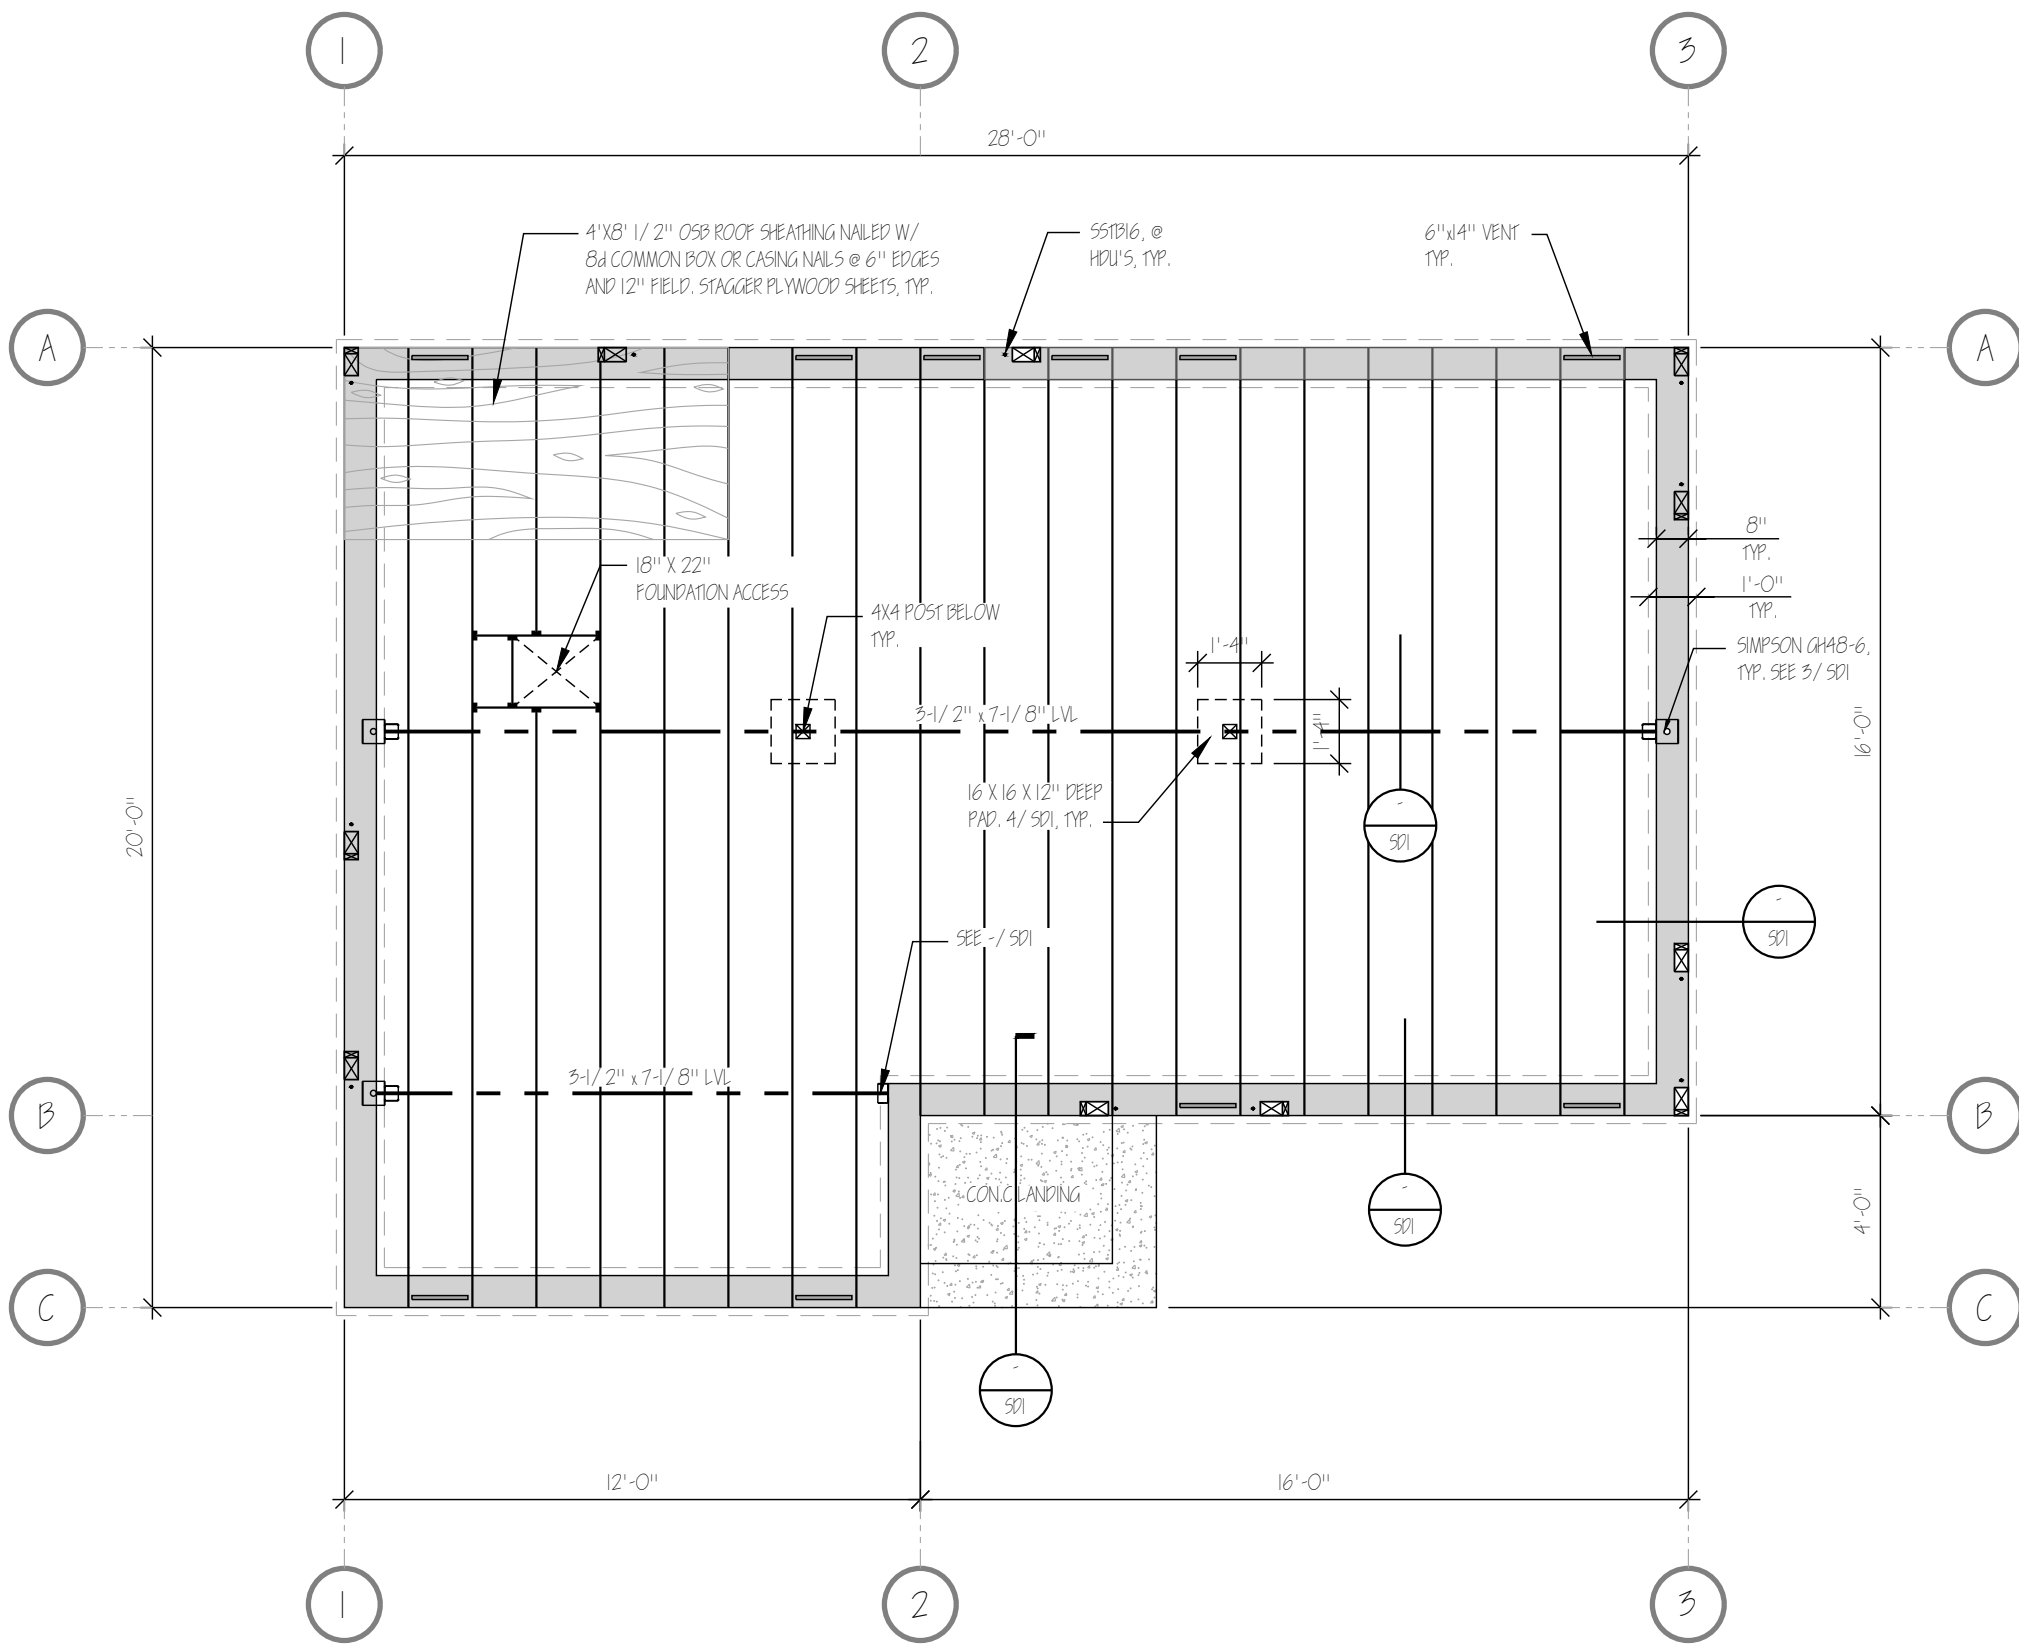

FOUNDATION PLAN  
SCALE: 1/4" = 1'-0"

FOUNDATION VENT SCHEDULE:	
14" X 6" G.S.M. VENTS = 0.56 FREE FLOW AREA	
TOTAL AREA = 496 SQ. FT. / 160 = 3.10 SQ. FT. REQUIRED	
10 - 6 X 14 G.S.M. FOUNDATION VENTS = 5.60 SQ. FT.	
TOTAL AREA PROVIDED	= 5.60 SQ. FT.

SHEAR WALL SCHEDULE				
SYMBOL	SHEARING & EDGE WALLS	ANCHOR BOLTS	NOTES	HP.
1	1/2" CDX PL WOOD W/ BA @ 6" O.C. E.N. & 12" O.C. FIELD	5/8" Ø X 12" O.C. @ 12" O.C. (2 BOLTS MIN.) 7" MIN. EMBEDMENT, 12" O.C. MAX. SPACING. USE 555B6 @ HOLDINGS PER PLAN	1,2,3	HP12
2	1/2" CDX PL WOOD W/ BA @ 4" O.C. E.N. & 12" O.C. FIELD	5/8" Ø X 12" O.C. @ 48" O.C. MIN. (2 BOLTS MIN.) 7" MIN. EMBEDMENT, 12" O.C. MAX. SPACING. USE 555B6 @ HOLDINGS PER PLAN	1,2,3	HP12
3	1/2" CDX PL WOOD W/ BA @ 4" O.C. E.N. & 12" O.C. FIELD	5/8" Ø X 12" O.C. @ 52" O.C. MIN. (2 BOLTS MIN.) 7" MIN. EMBEDMENT, 12" O.C. MAX. SPACING. USE 555B6 @ HOLDINGS PER PLAN	1,2,3	HP12

NOTE 1: USE #16 MIN. AT TIE-DOWNS OR 555B2 - 2x6 WITH 16 @ E.N. SPACING UNO.  
NOTE 2: USE 4X MIN. AT SHEARING JOINTS. SPACER NAILS AT JOINTS  
NOTE 3: HOLDINGS WHERE NOTED